


PROPOSED LICENSING FLOOR PLAN

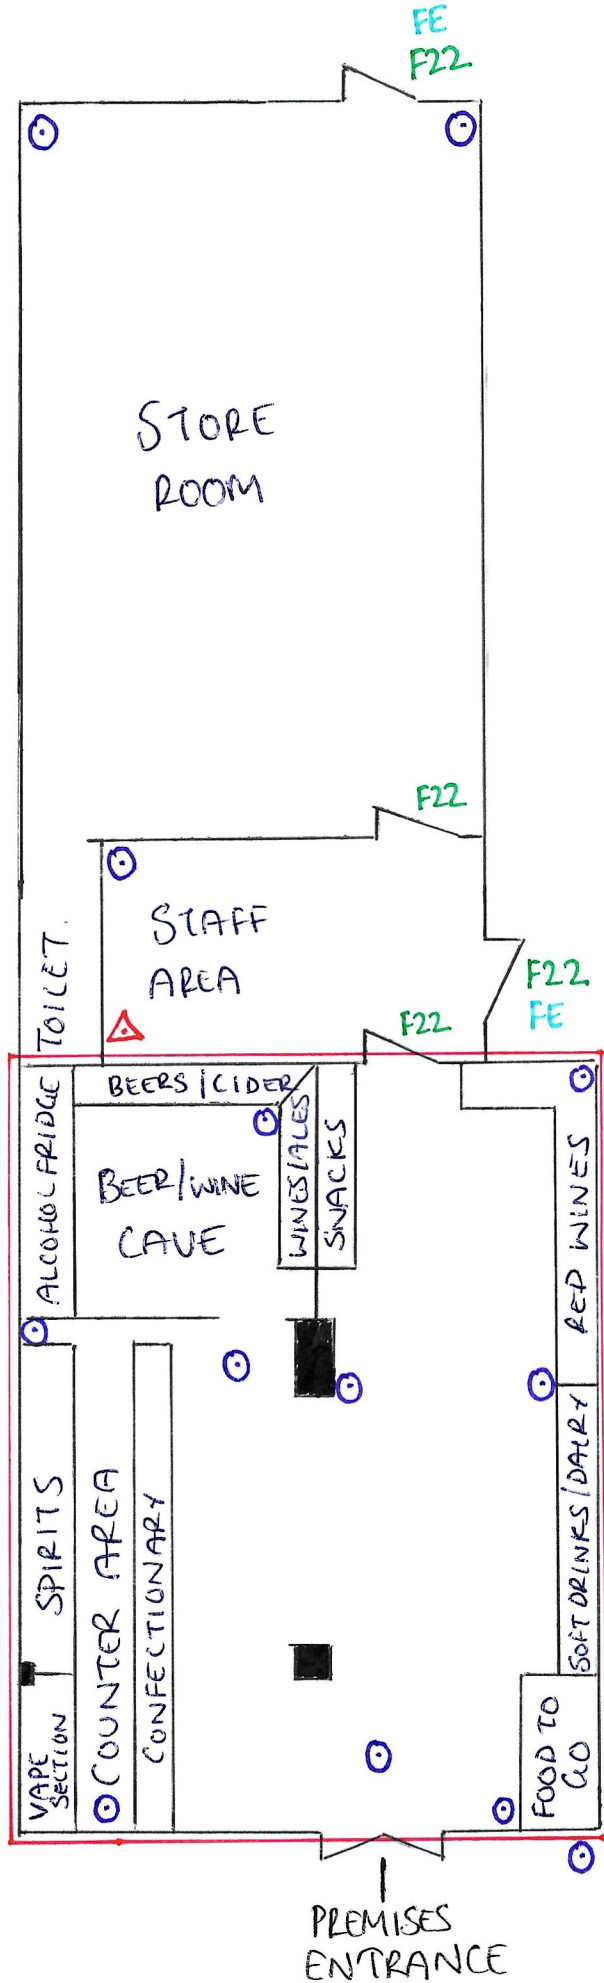

PREMISES DETAILS:  
 LIQUOR & VAPE SHOP  
 158 ALDERSHOT ROAD  
 CHURCH CROOKHAM  
 FLEET.  
 GU52 8JT.

KEY:  
 LICENSABLE  
 ACTIVITY AREA  
 ○ CCTV  
 F22 FIRE EXIT SIGN  
 FE FIRE EXIT.  
 ▲ FIRE EXTINGUISHER.  
 SCALE: 1:100